

DREDGING NOTICE
U.S. ARMY CORPS OF ENGINEERS
ST. PAUL DISTRICT

NOTICE DATE: July 8th, 2026

MEETING DATE: If requested

BOAT REQUIREMENT:

DREDGE CUT NAME: Root River

DREDGING CATEGORY: Emergency

MEETING TIME:

MEETING LOCATION:

RIVER MILE: 693.6 – 693.7

HISTORIC DATA

Frequency: 23%

Last Date Dredged: October 24th, 2022Avg. Quantity/Job: 14,003 yd³Avg. Quantity/Year: 3,251 yd³

SURVEY DATA

Date Surveyed: July 7th, 2026

Water Surface Elevation: 630.8

Low Control Pool Elevation: 630.1

Net Difference: +0.7'

5 Day River Forecast: Holding Steady

DREDGING DATA

Recommended Channel Width: 300 feet

Recommended Dredging Depth: 11 feet

Estimated Quantity: 3,963 yd³

Type of Dredge: Contract Mechanical Plant 1

Proposed Dredging Date: July 8th, 2026

Estimated Duration: 2 dredging days

Justification for Dredging: The navigation channel is restricted on the right descending bank by a very shallow point bar which causes the channel to be reduced to 240' between the 9.0' contours.

MATERIAL PLACEMENT DATA


Proposed Placement Site: Isle La Plume

Location: 8-696.1-LWP


Site Characteristics: This is a historically used upland placement site. All material is expected to be removed.

If you have any questions concerning this project, or if you would like to request an onsite meeting, please call me at (651) 350-2564.

Channel Maintenance Coordinator

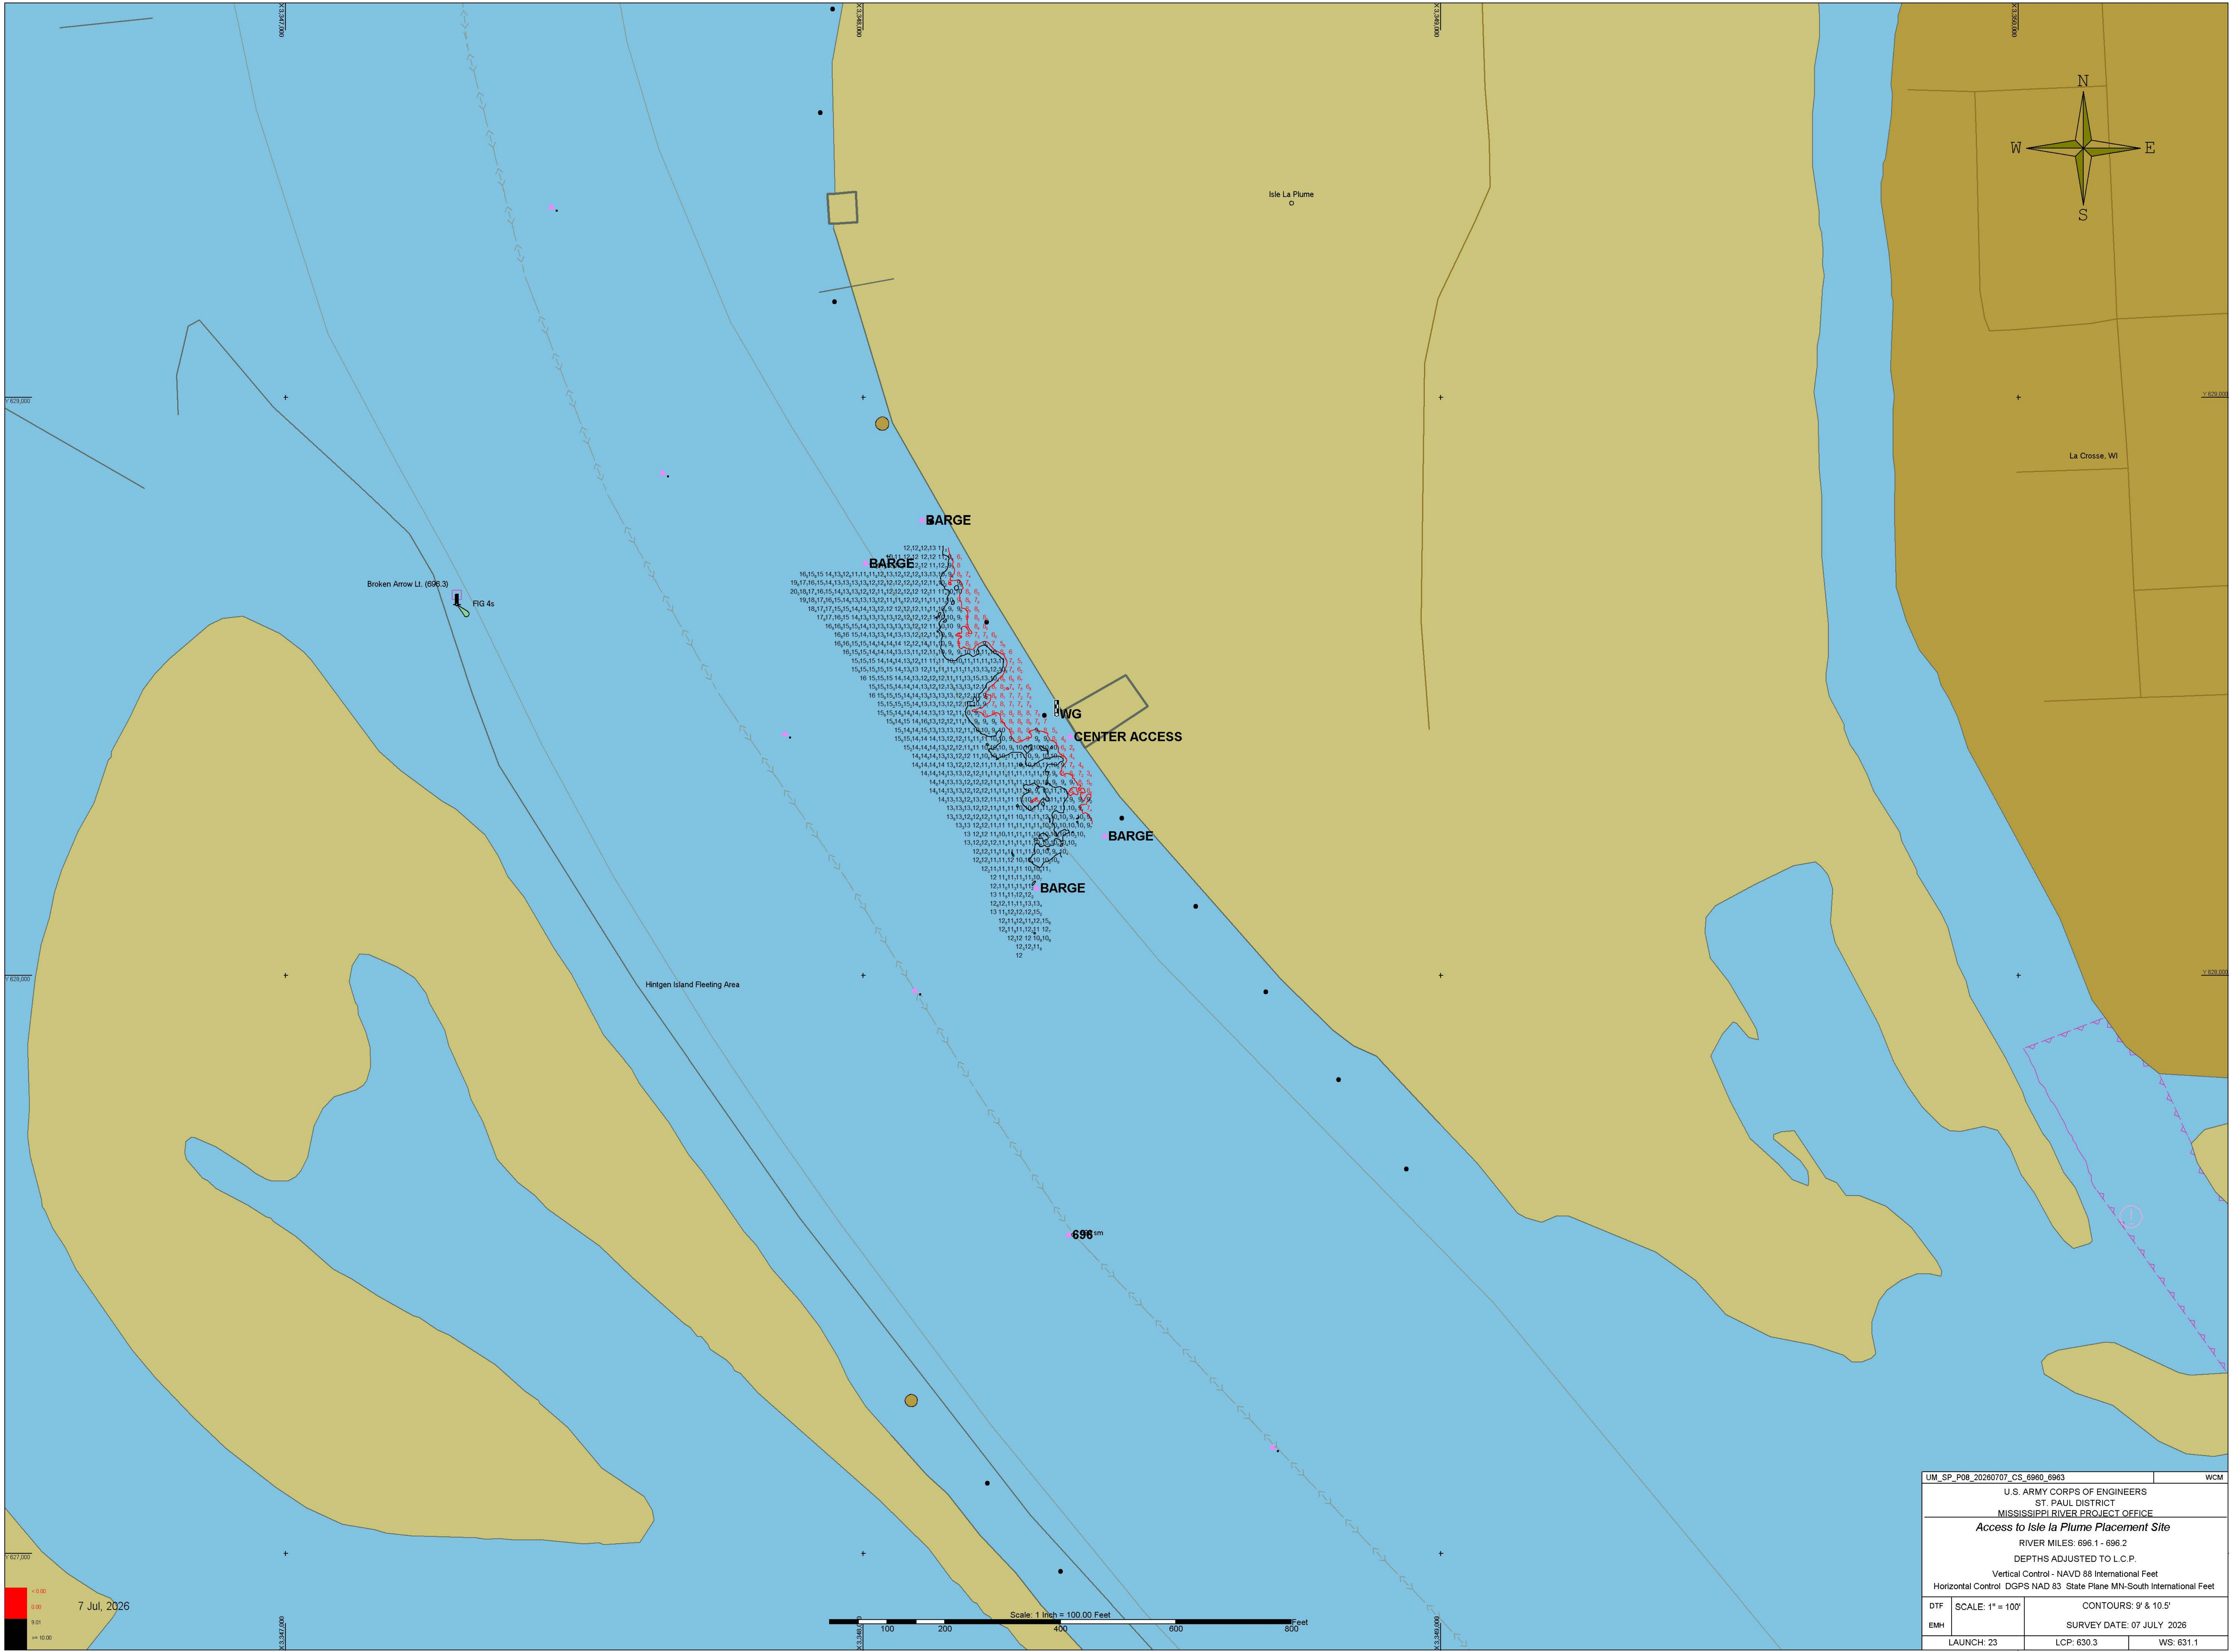

UM_SP_P08_20260707_CS_6960_6963		WCM
U.S. ARMY CORPS OF ENGINEERS ST. PAUL DISTRICT MISSISSIPPI RIVER PROJECT OFFICE		
Access to Isle la Plume Placement Site		
RIVER MILES: 696.1 - 696.2		
DEPTHS ADJUSTED TO L.C.P.		
Vertical Control - NAVD 88 International Feet		
Horizontal Control DGPS NAD 83 State Plane MN-South International Feet		
DTF	SCALE: 1" = 100'	CONTOURS: 9' & 10.5'
EMH		SURVEY DATE: 07 JULY 2026
LAUNCH: 23	LCP: 630.3	WS: 631.1

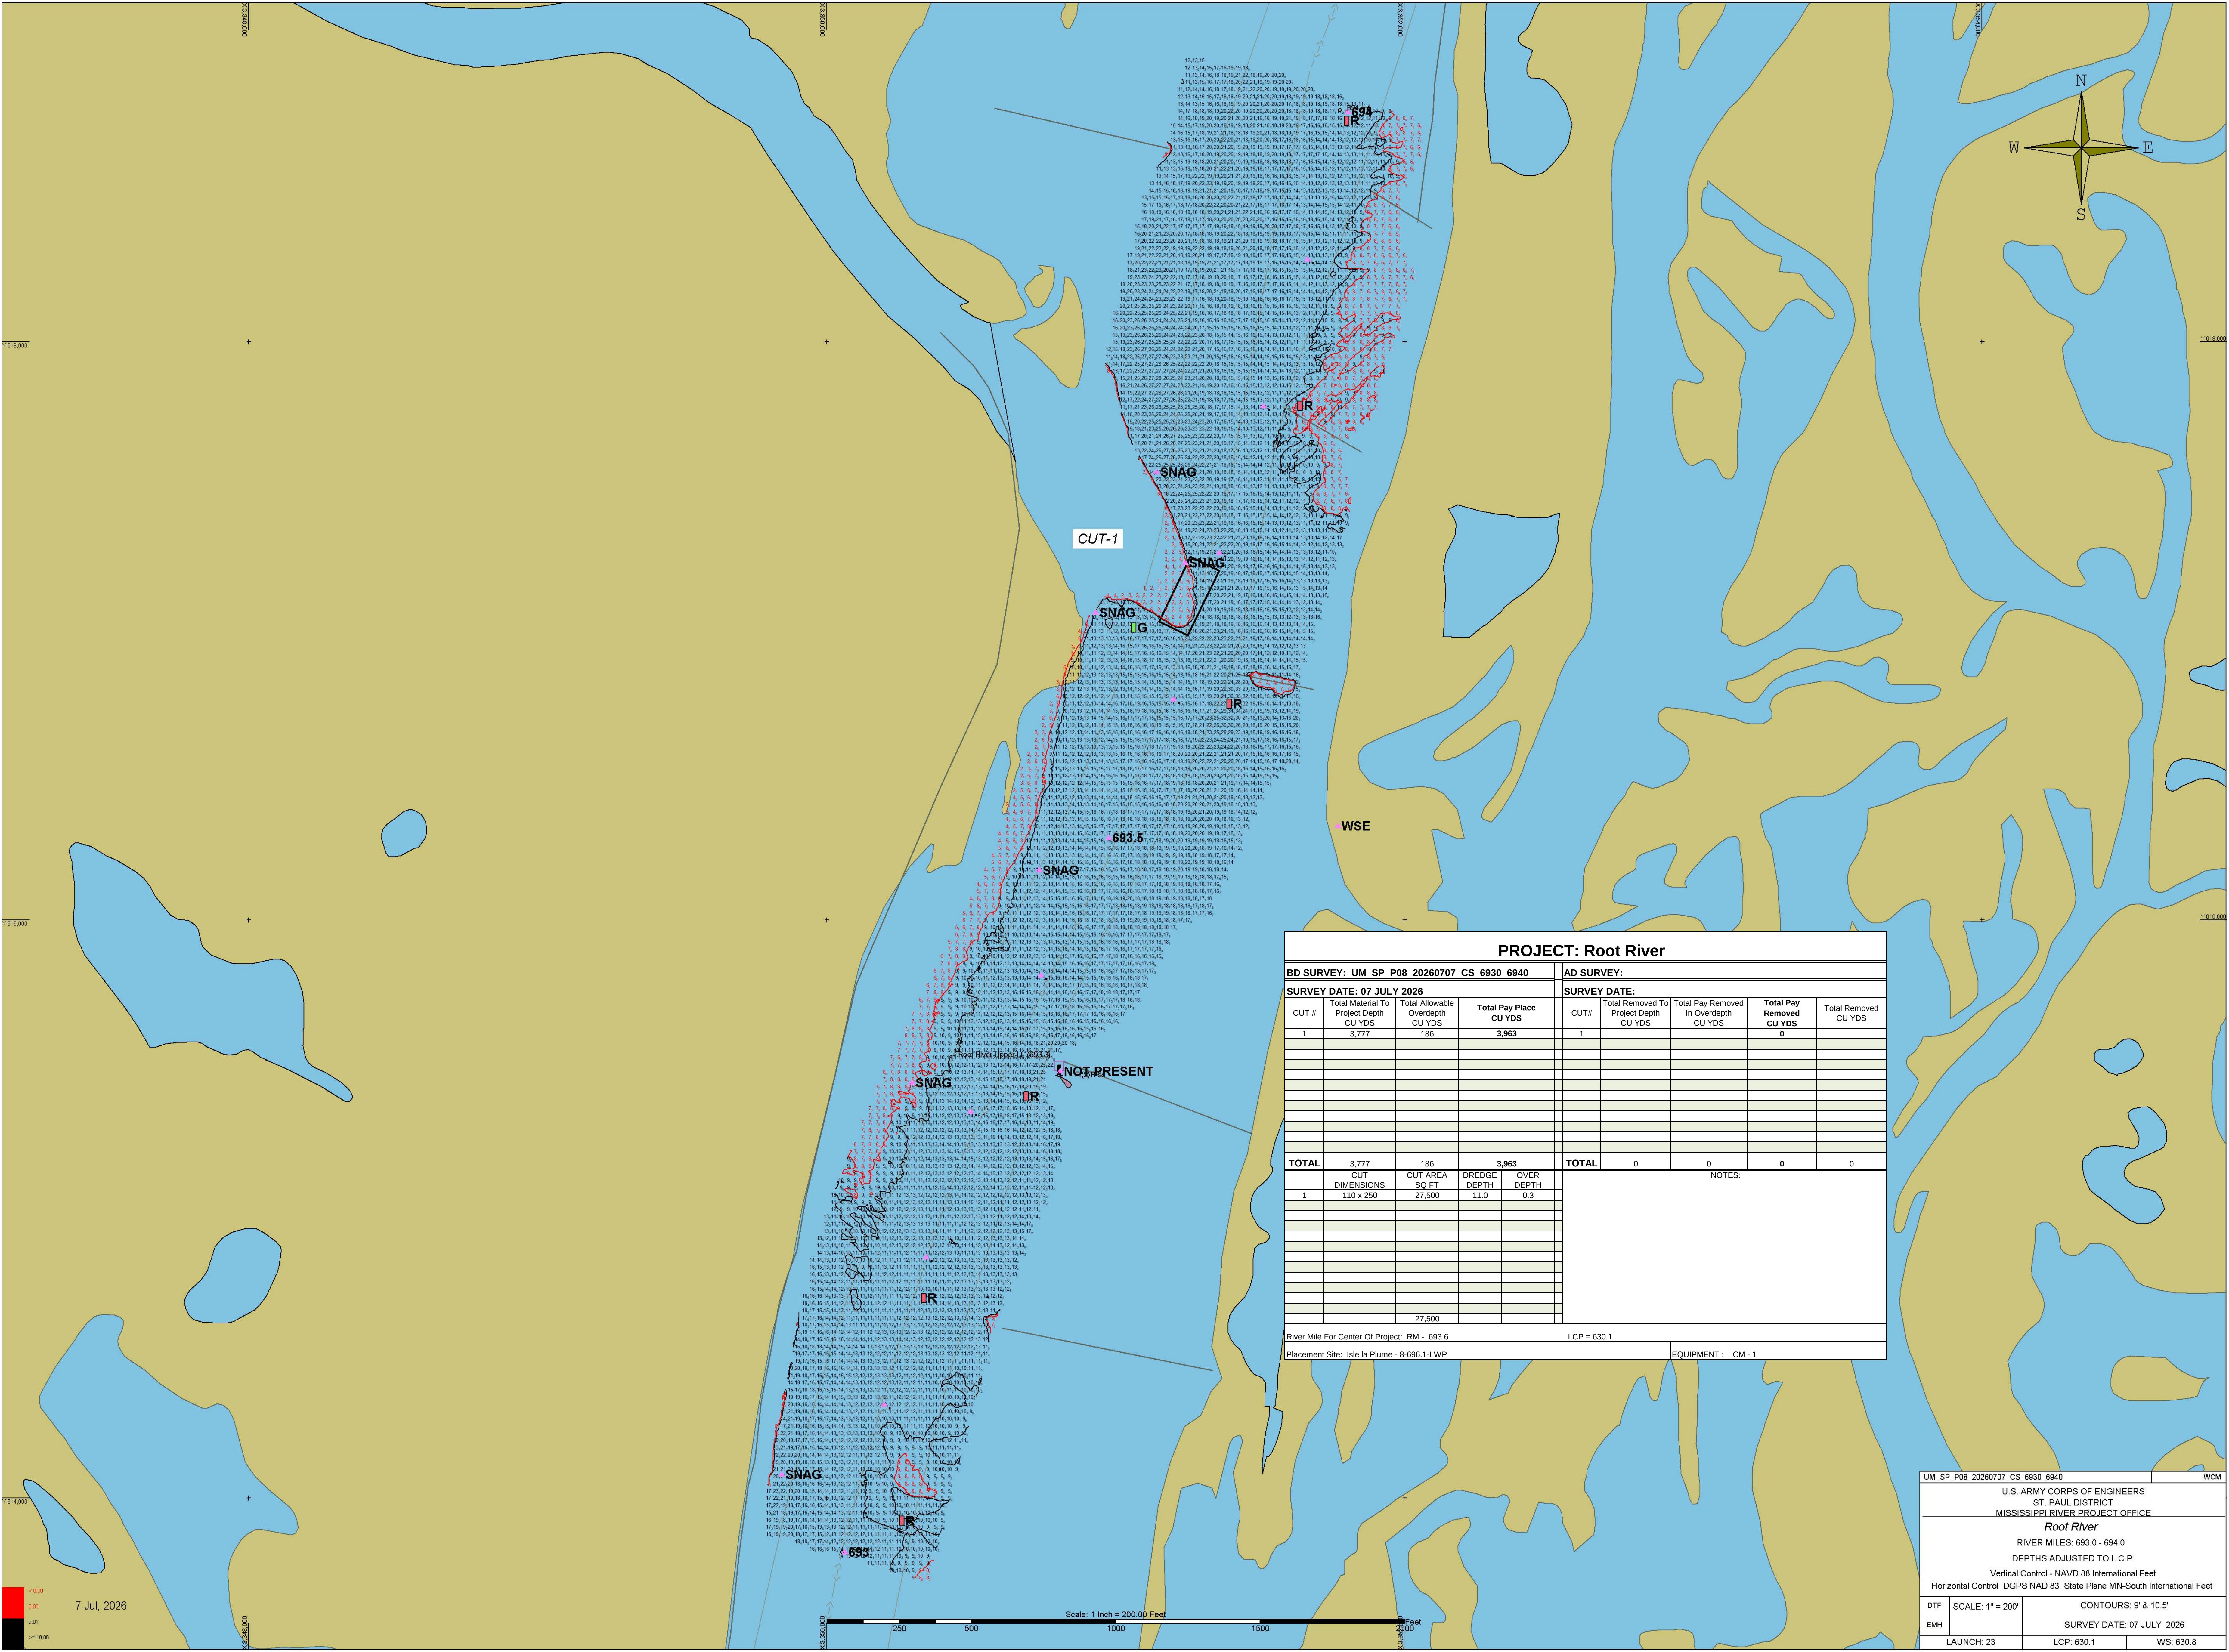

UM_SP_P08_20260707_CS_6930_6940		WCM
U.S. ARMY CORPS OF ENGINEERS		
ST. PAUL DISTRICT		
MISSISSIPPI RIVER PROJECT OFFICE		
Root River		
RIVER MILES: 693.0 - 694.0		
DEPTHS ADJUSTED TO L.C.P.		
Vertical Control - NAVD 88 International Feet		
Horizontal Control DGPS NAD 83 State Plane MN-South International Feet		
DTF	SCALE: 1" = 200'	CONTOURS: 9' & 10.5'
EMH	SURVEY DATE: 07 JULY 2026	
LAUNCH: 23	LCP: 630.1	WS: 630.8